


- LEGEND**
- SERVICE PENETRATIONS (VENTS) ○
  - MECHANICAL PLANT □
  - MECHANICAL PLANT SUPPORTS □
  - SKYLIGHT □

**NOTE:**

- THE PLAN ADJACENT INDICATES WHERE THE PENETRATIONS ARE LOCATED THROUGH THE ROOF AS NOTED IN THE LEGEND ABOVE.
- CEILING TILES ARE TO BE REMOVED AT THESE LOCATIONS TO INSPECT ROOF SOFFIT PRIOR TO THE SITE VISIT BY WSP ENGINEERS.
- AN ASBESTOS SURVEYOR SHOULD BE PRESENT WHEN TILES ARE REMOVED.
- CONSULTATION WITH INFECTION CONTROL AND CLINICAL STAFF SHOULD BE CARRIED OUT PRIOR TO REMOVAL OF ANY CEILING TILES.

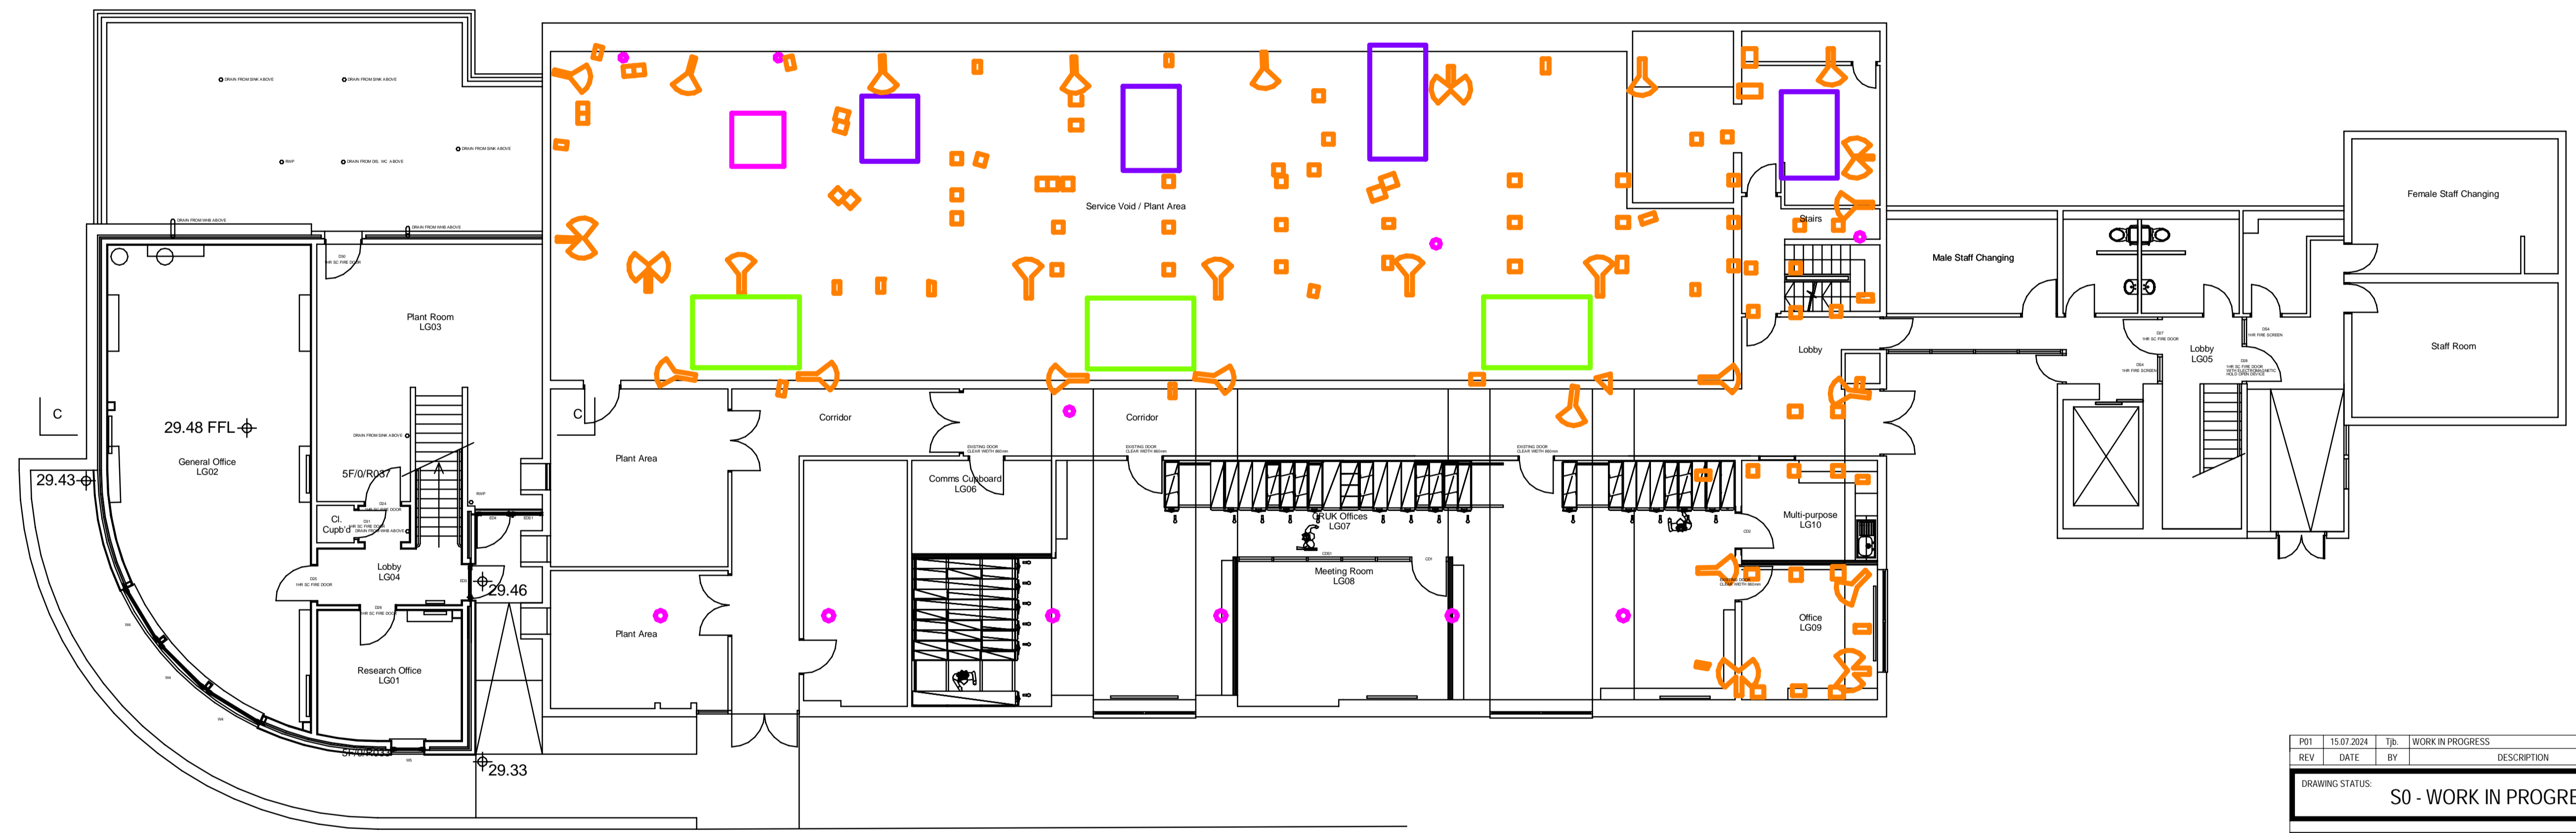

**FIRST FLOOR PLAN.**  
1 : 100

**NOTE:** THIS DRAWING HAS BEEN PRODUCED WITH THE INTENTION OF BEING VIEWED IN A COLOUR FORMAT FOR THE PURPOSE OF CLARITY. DO NOT COPY OR PRINT TO BLACK AND WHITE.

REV	DATE	BY	DESCRIPTION	CHK	APP
P01	15.07.2024	Tjb	WORK IN PROGRESS	CJ	MGP

DRAWING STATUS: **S0 - WORK IN PROGRESS**



7th Floor, 110 Queen St, Glasgow G1 3BX  
Tel: +44 141 429-3555 Fax: +44 141 429-3666  
<http://www.wsp.com>

CLIENT: **NHSCOTLAND ASSURE**

ARCHITECT: -

PROJECT: **WESTERN GENERAL HOSPITAL  
MCMILLAN CANCER CARE**

TITLE: **LOCATION OF ROOF PENETRATIONS  
AND MECHANICAL PLANT TO ROOF**

SCALE @ A1:	CHECKED:	APPROVED:
NTS	CJ	MGP

PROJECT NUMBER:	DESIGNED:	DRAWN:	DATE:
70098755	CJ	Tjb	12 JULY 2024

DRAWING No:	REV:
RAAC-WSP-ZZ-ZZ-DR-S-02702	P01