



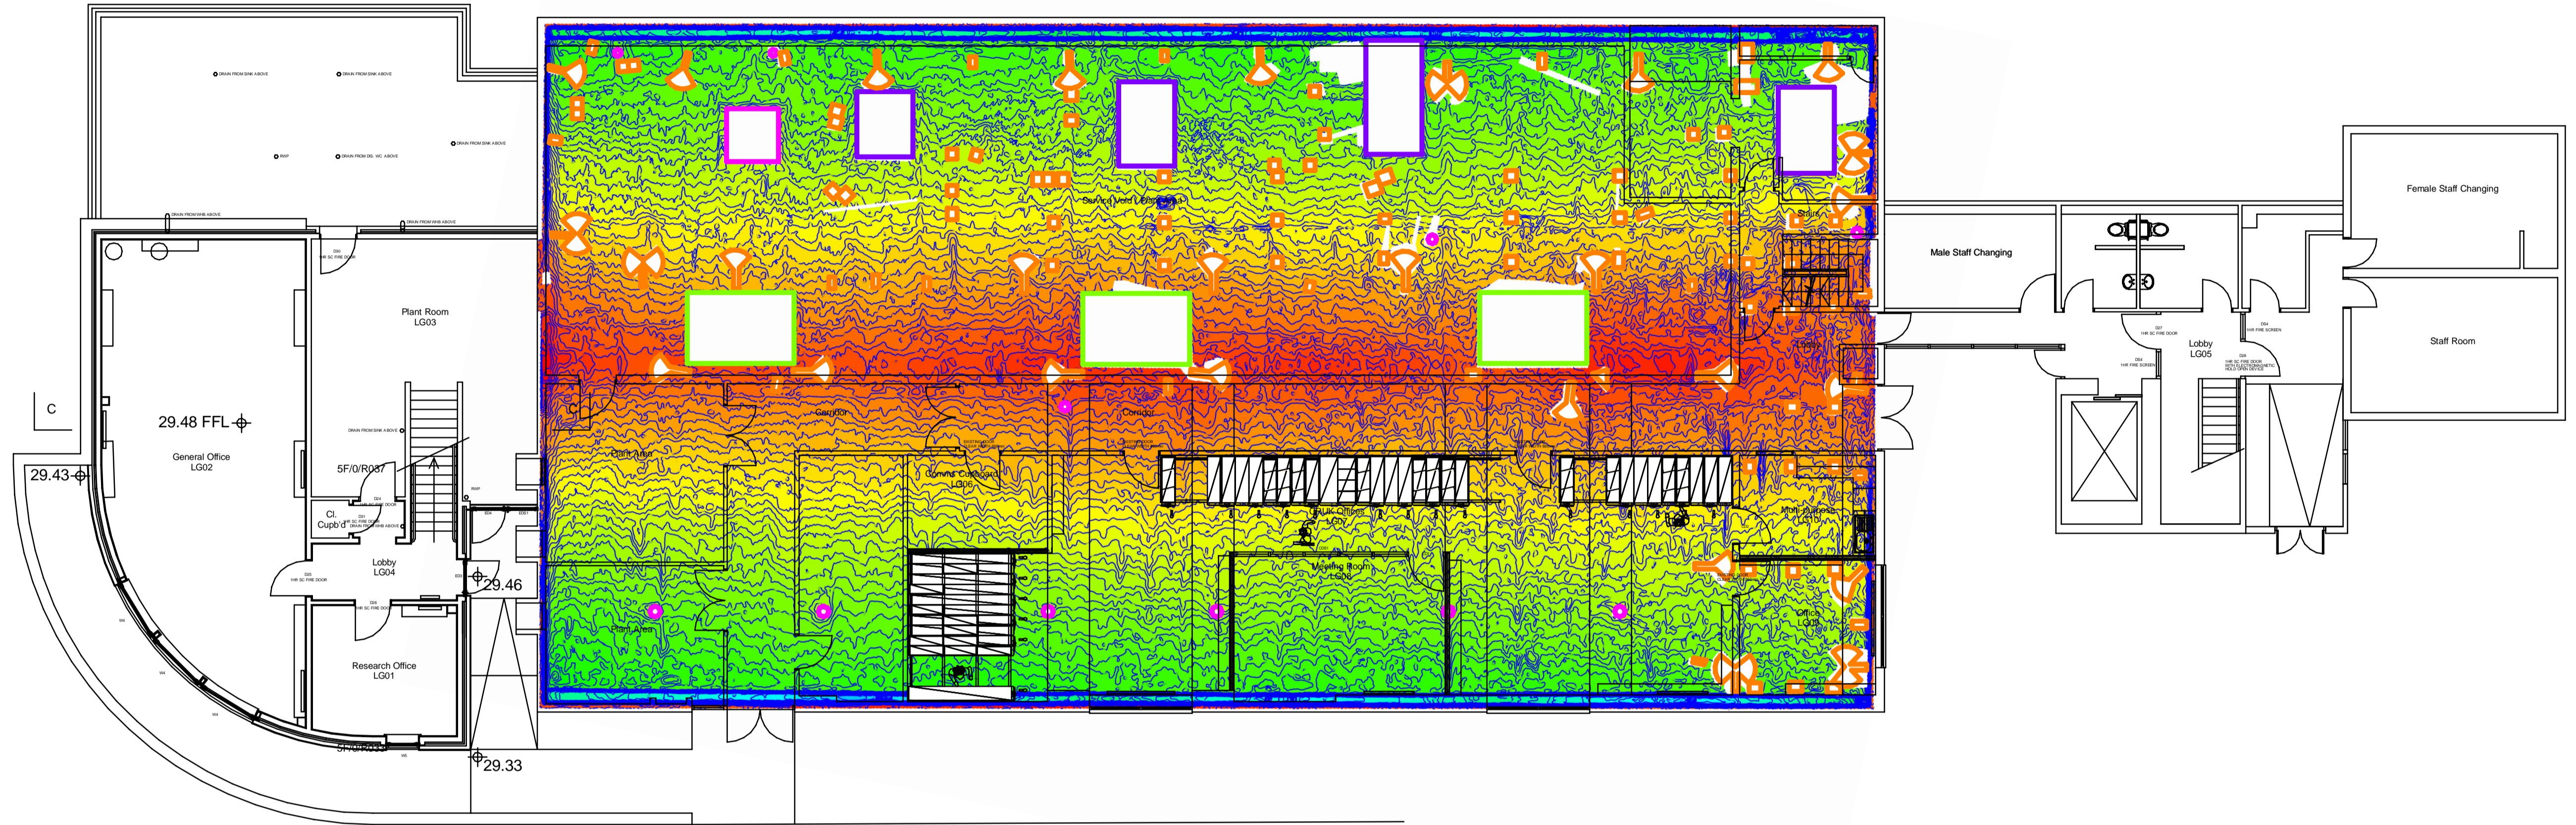
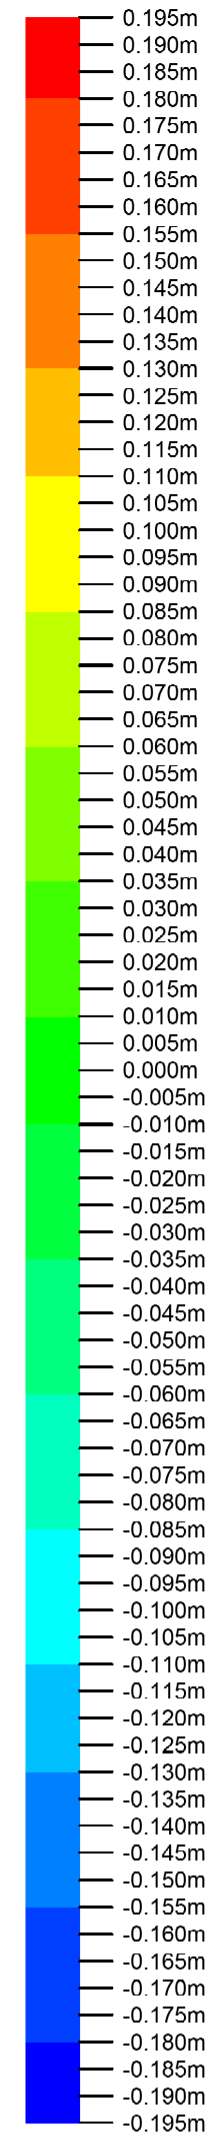


DO NOT SCALE

- LEGEND
- SERVICE PENETRATIONS (VENTS) 
  - MECHANICAL PLANT 
  - MECHANICAL PLANT SUPPORTS 
  - SKYLIGHT 



NOTE:

- THE COLOURS IN THE LEGEND ABOVE INDICATE THE DISTANCE FROM DATUM UP AND DOWN WITH A RANGE OF PLUS OR MINUS 0.195m (195mm).
- THE CONTOURS ARE INDICATED ON THE PLAN ARE PLUS OR MINUS 5mm.

NOTE: THIS DRAWING HAS BEEN PRODUCED WITH THE INTENTION OF BEING VIEWED IN A COLOUR FORMAT FOR THE PURPOSE OF CLARITY. DO NOT COPY OR PRINT TO BLACK AND WHITE.

REV	DATE	BY	DESCRIPTION	CHK	APP
P01	15.07.2024	TJB	WORK IN PROGRESS	CJ	MGP

DRAWING STATUS: **S0 - WORK IN PROGRESS**



7th Floor, 110 Queen St, Glasgow G1 3BX  
Tel: +44 141 429-3555 Fax: +44 141 429-3666  
<http://www.wsp.com>

CLIENT: **NHSCOTLAND ASSURE**

ARCHITECT: -

PROJECT: **WESTERN GENERAL HOSPITAL  
MCMILLAN CANCER CARE**

TITLE: **ROOF DEFLECTION HEAT MAP**

SCALE @ A1:	CHECKED:	APPROVED:
NTS	CJ	MGP

PROJECT NUMBER:	DESIGNED:	DRAWN:	DATE:
70098755	CJ	Tjb	12 JULY 2024

DRAWING No:	REV:
RAAC-WSP-ZZ-ZZ-DR-S-02701	P01

© WSP UK Ltd

RAAC-WSP-ZZ-ZZ-DR-S-02701.dwg 15/07/2024 15:10:28

Last saved in AutoCAD 2024